


Electrical Single Line Diagram for Electric Vehicle Service Equipment

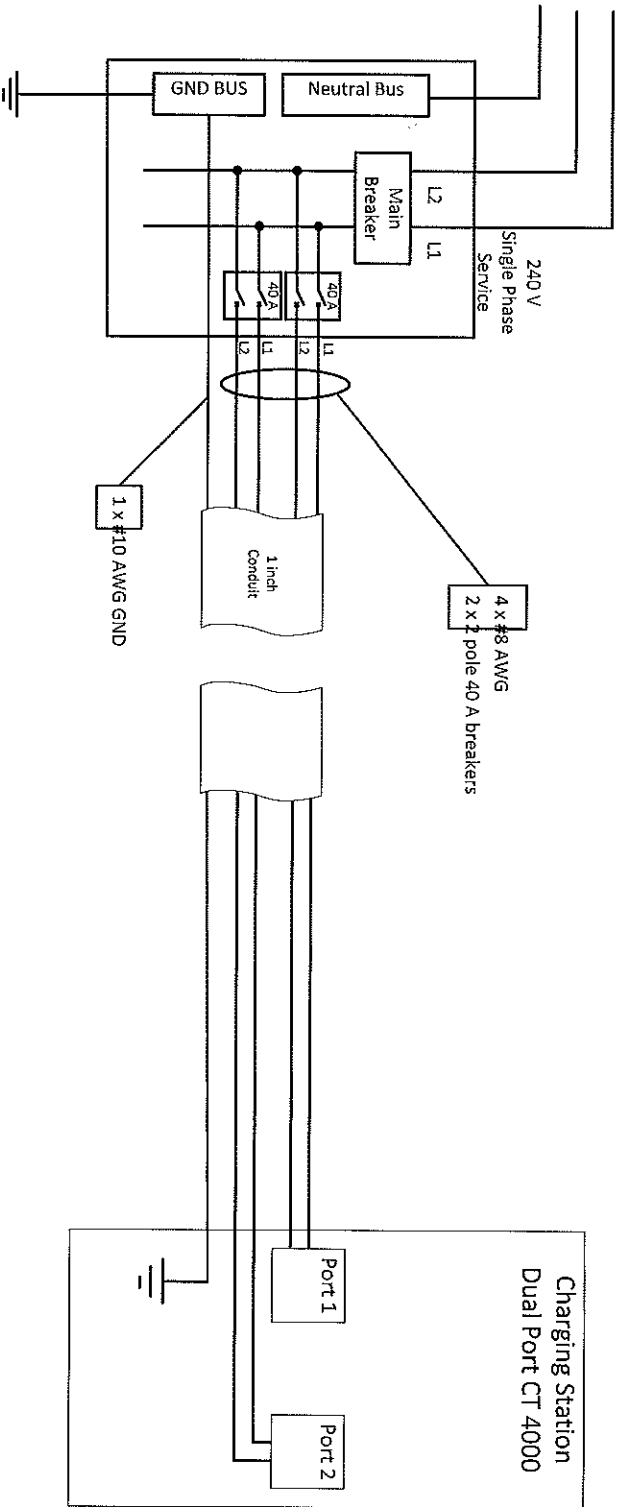

PlugIn Stations OnLine

DRAWN BY
DENIS COLLETT